


LEGEND

SYMBOL	DESCRIPTION	QTY.
	Kitchen	3,30
	Living Room	45,47
	Master Bathroom	4,74
	Foyer / Corridor	14,64
	Guests' Loo	1,60
	Master Bedroom	12,84
	Changing room	9,21
		91,80
	Home Office / Lounge	13,83
	Sauna	2,44
	Bathroom	3,36
	Mia's Bedroom	9,47
	Mae's Bedroom	11,60
	Mait's Bedroom	10,70
	Corridor	4,58
		36,35
	TOTALS	128,15

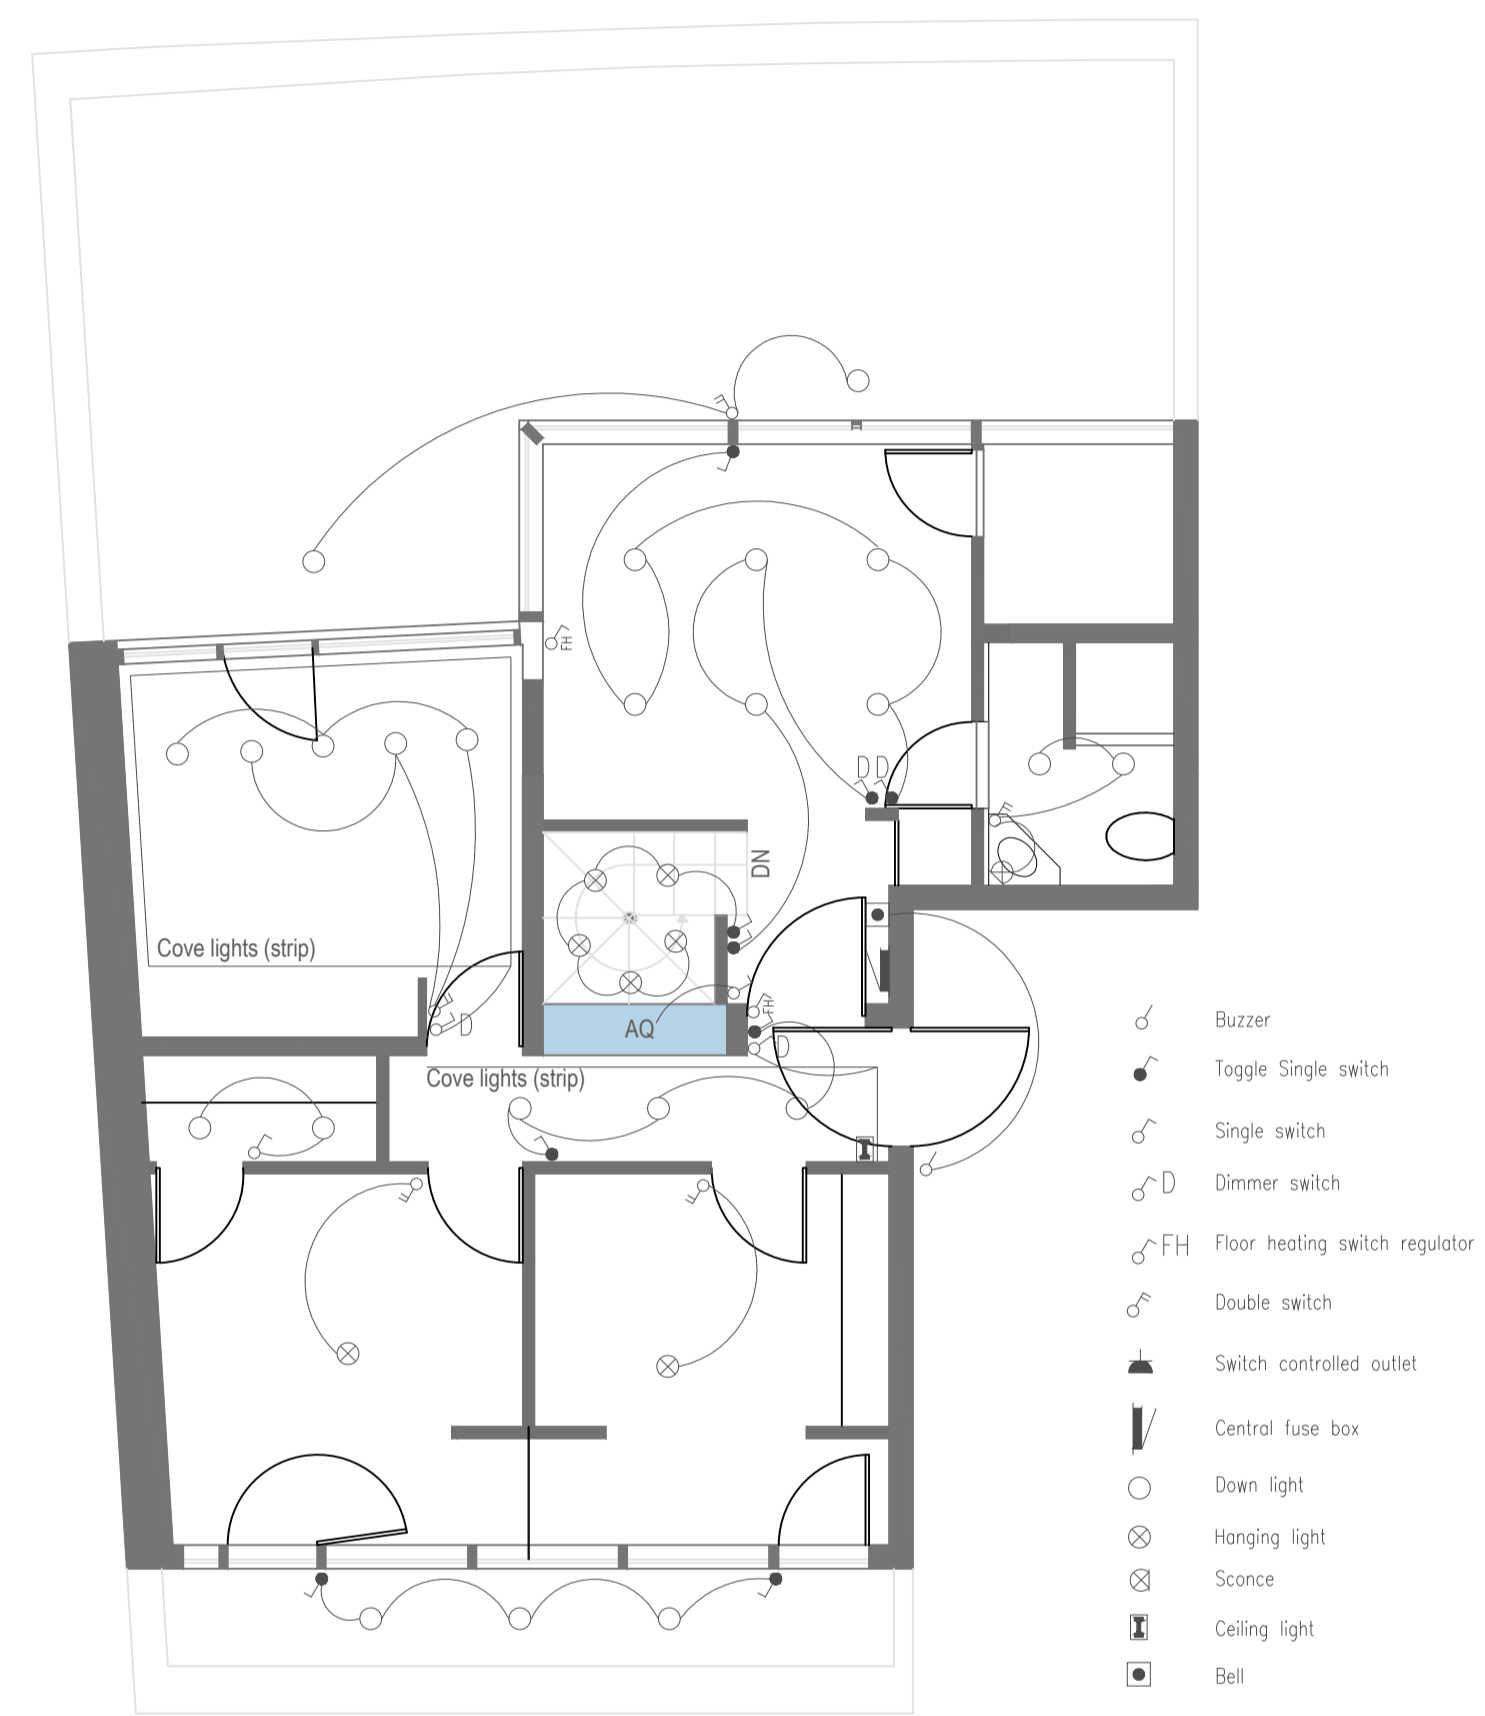

- ♂ Buzzer
- Toggle Single switch
- ⌚ Single switch
- ⌚ D Dimmer switch
- ⌚ FH Floor heating switch regulator
- ⌚ Double switch
- ⌚ Switch controlled outlet
- ▭ Central fuse box
- Down light
- ⊗ Hanging light
- ⊗ Sconce
- ⌚ Ceiling light
- Bell

6.			
5.			
4.			13.07.20
3.			
2.			
1.			
Nr.	Changes	By	Date

REMARKS: 1. THIS DRAWING MAKES ALL VERSIONS WITH PREVIOUS DATES OBSOLETE
 2. ALL CHANGES MUST BE CONFIRMED BY THE ARCHITECT
 3. ALL DIMENSIONS AND HEIGHTS MUST BE CHECKED AND CONFIRMED ON SITE DURING THE CONSTRUCTION PROCESS
 4.
 5.
 6.
 7.

Studio	EJ2 OÜ	Project	MOOSSEN RESIDENCE		
Design	JP	Address	Narva mnt 128, Apt. 91, D wing, Tallinn		
		Dwg Title	2ND FLOOR ELECTRICAL PLAN	Dwg Nr	A-05
		Work Nr 00-00	Stage	PHASE 1	Date 27/07/20
Even Just Two, Tartu mnt 84a, Tallinn 10112		www.evenjusttwo.com		Tel +372 52 75366	